 



LEGEND

	AREA UNDER SERVICES - 2.56 Ac.
---	--------------------------------

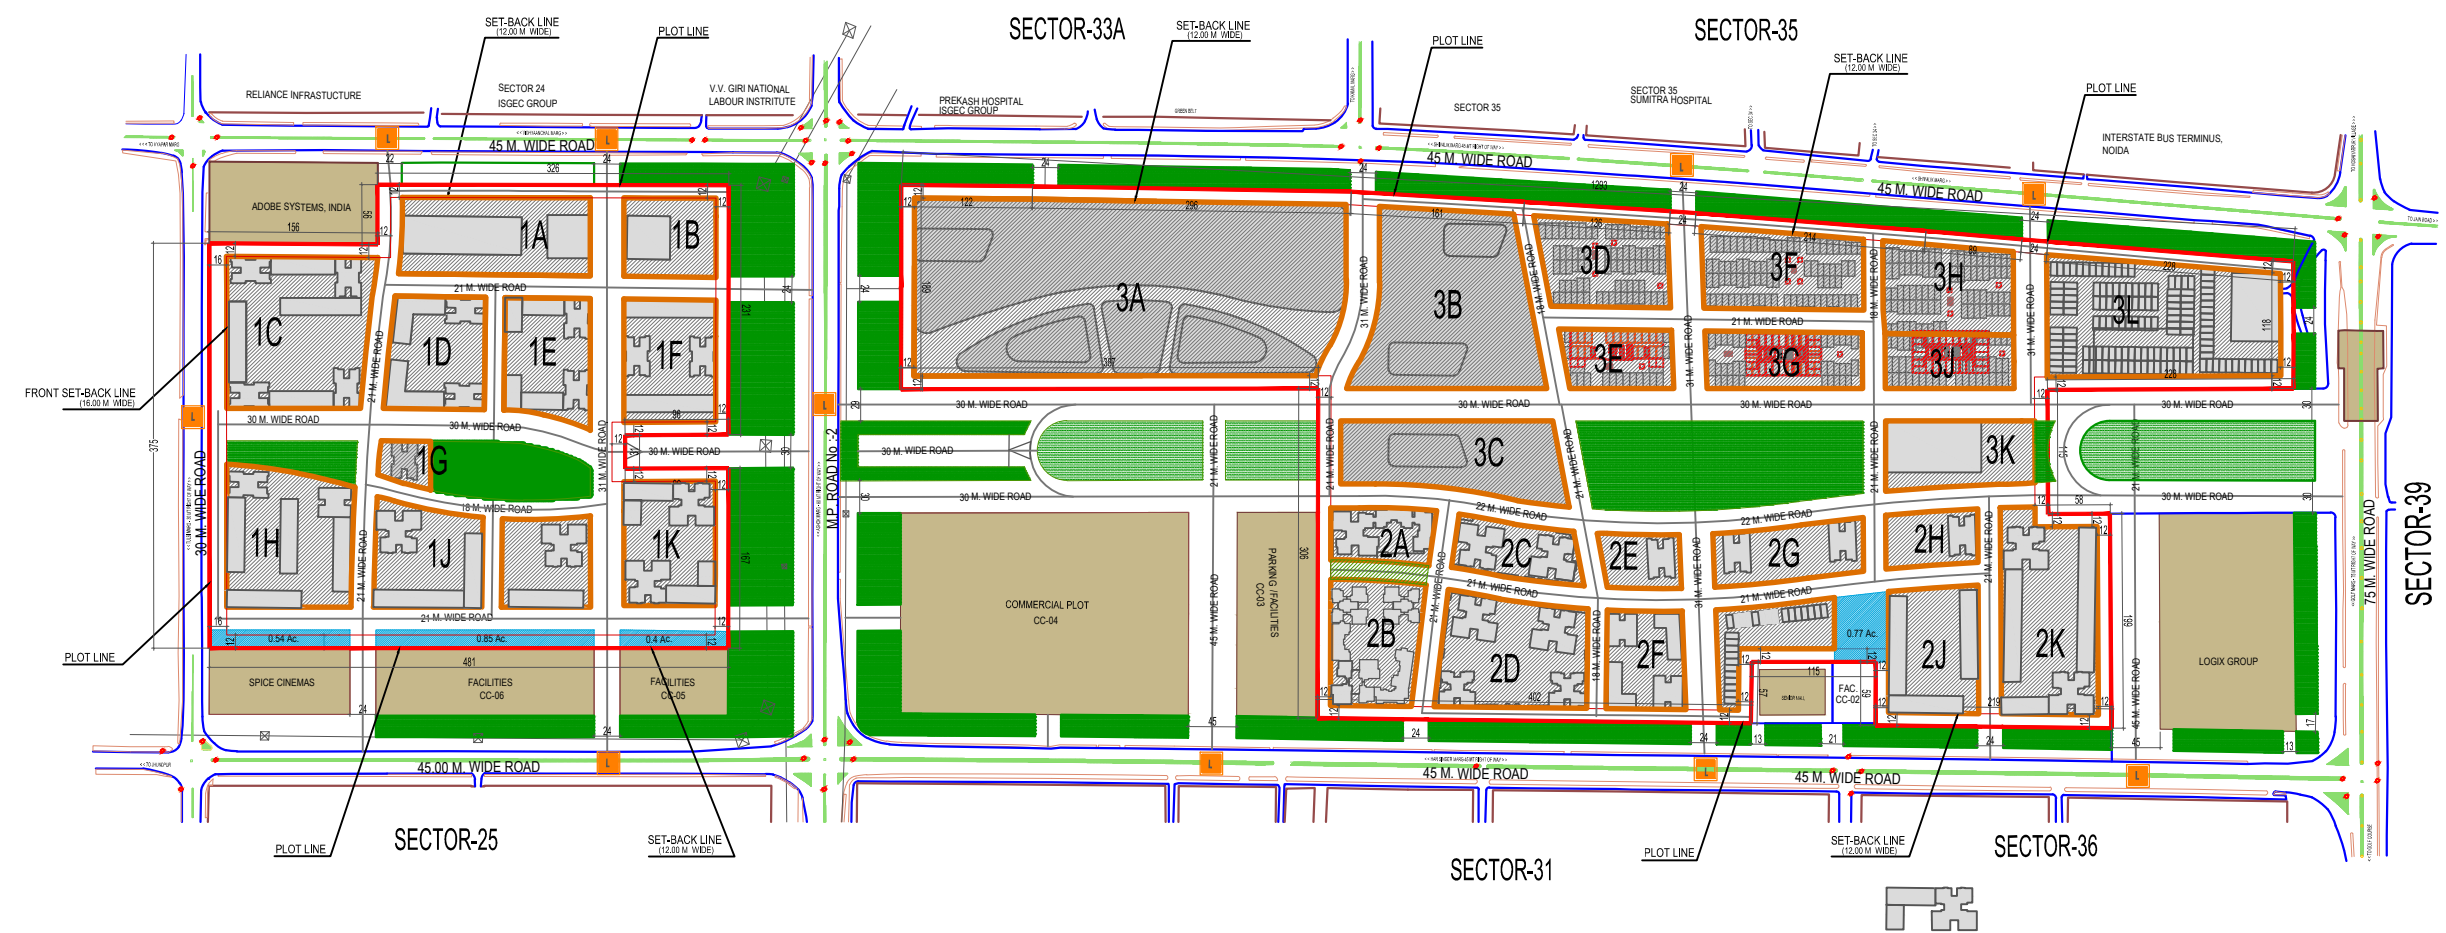

DRAWING TITLE:
SITE PLAN

PROJECT:
**PROPOSED WAVE CITY CENTER,
SECTOR 25A /32, NOIDA - 152 ACRES**

CONSULTANTS:
AECOM
9th Floor, Infinity Tower C DLF Cyber City, DLF Phase II Gurgaon 122002 Haryana, India


ARCHITECT'S SIGNATURE: _____ TOWN PLANNER'S SIGNATURE: _____

OWNER'S SIGNATURE: _____

CLIENTS:
WAVE MEGA CITY CENTRE PVT. LTD.

JOB NO. _____

SCALE:
1:2500

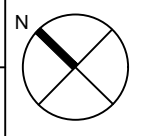

DATE:
XXXXXX

DRAWING NO.
MP-04

DRAWN BY: _____ CHECKED BY: _____ REVISION NO. _____

NOIDA AUTHORITY:

ASSOCIATE ARCHITECT	ARCHITECT	CHIEF ARCHITECT
---------------------	-----------	-----------------

1:3237.27